


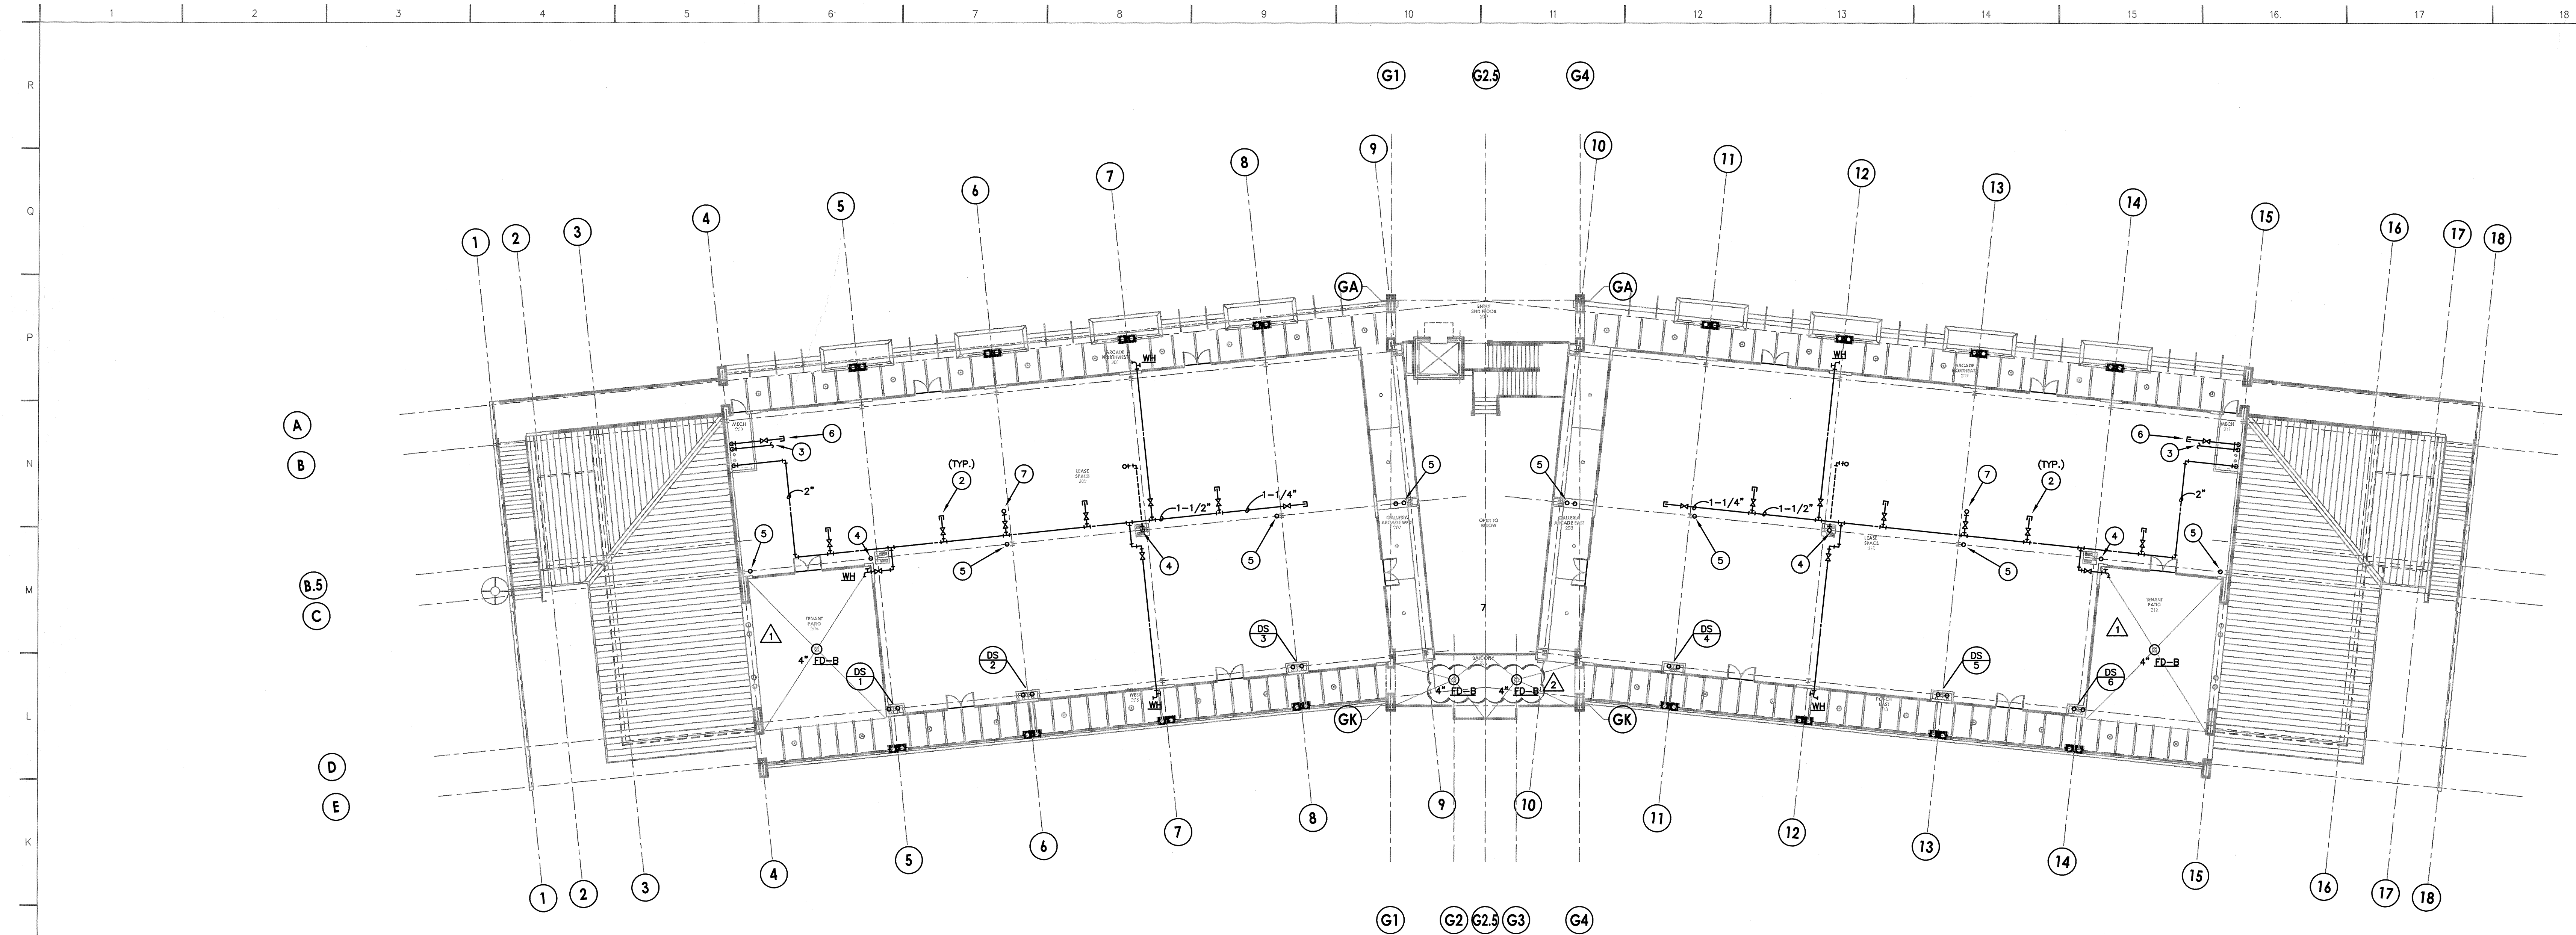

01 SECOND FLOOR PLUMBING PLAN
Scale: 1/16"=1'-0"

DRAWING NOTES:


- ① 2-1/2" OVERHEAD TENANT COLD WATER LINE.
- ② 1-1/4" VALVED AND CAPPED TENANT WATER CONNECTION.
- ③ FIRE SPRINKLER LINE.
- ④ GREASE WASTE WET STACK.
- ⑤ SANITARY SEWER WET STACK.
- ⑥ 2" GAS SERVICE VALVED AND CAPPED FOR FUTURE TENANT.
- ⑦ 3/4" COLD WATER LINE UP FOR MAPA MPH-24 FP FREEZE PROOF PEDESTAL HYDRANT SERVICE.

SUSMAN TISDALE GAYLE
ARCHITECTURE - PLANNING - INTERIORS
AUSTIN - NASHVILLE



TEL 512.899.3500
FAX 512.899.3501

4330 S. MOPAC EXPWY
SUITE ONE HUNDRED
AUSTIN TEXAS 78735
www.stgarch.com

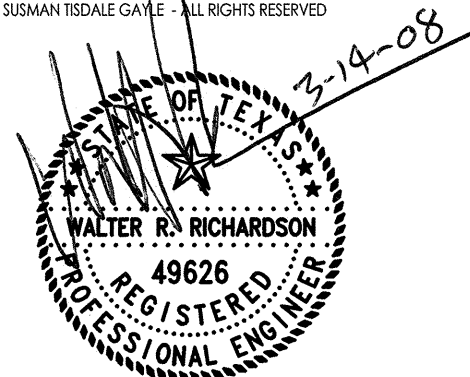

MEI & ASSOC., INC.
Consulting Engineers
811 Barton Springs Blvd.
Austin, TX 78704
512-452-9701

LADERA BEND

PACKAGE B
RETAIL BUILDING

Project 16-5236-00
Drawn 08.01.06
Quality Control SMM
Project Director

Issues
△ CONSTRUCTION 02-02-07
△ PR # 6 11-29-07
△ PR #10 03-14-08

**SECOND FLOOR
PLUMBING PLAN**

P2.02